


NOTES: Do not scale this drawing. All dimensions to be checked on site prior to commencement or manufacture.

Key Plan (nts)

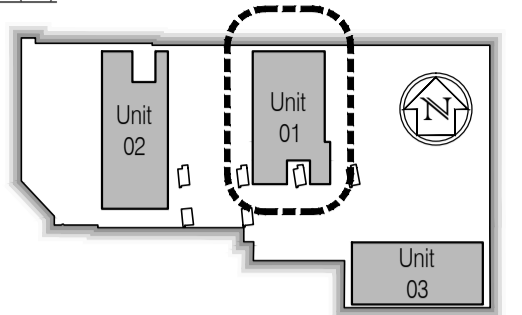

Floor Finishes Legend:

Denotes non-slip vinyl safety flooring, with covered skirtings throughout, with proprietary cove formers and nosings to skirting tops.

Denotes 600 x 600mm format carpet tiling throughout, with nom. 22 x 200mm painted MR-MDF skirtings to all wall faces.

NOTE: Carpet tiles to be fully adhered to substrate. Vinyl flooring to be hot-welded jointed at all joints / junctions. Ensure to provide threshold strips (located hidden beneath door leaves) to all room junctions, allowing for movement in vinyl as necessary.

Ceiling Finishes Legend:

Denotes 600 x 600mm lay-in grid suspended ceiling system, with washable humidity resistant tiles, and proprietary shadow-gap edge-trim throughout.

Denotes nom. 1100mm wide insulated cold-room paneling design / spec / details to be confirmed by the Specialist Supplier / Contractor

NOTE: Final cold-room paneling design / spec / details to be confirmed by the Specialist Supplier / Contractor

CONSTRUCTION ISSUE

Rev	Date	By	Clk	Comment
04	10.03.11	JAS	AC	Updated as latest layout amendments
03	22.11.10	JAS	AC	Issued for Construction
02	15.10.10	RKC	JAS	Dock leveller and platform revised.
01	08.10.10	RKC	JAS	Issued for Tender

BRINGING IDEAS TO LIFE



FRANKHAM

Frankham Consultancy Group Limited
 21 Perrymount Road
 Haywards Heath, RH16 3TP
 t 01444 444900 f 01444 455642
 enquiry@frankham.com
 www.frankham.com

Client


Project Title
 Euston Station
 Parcel Deck
 Rail Gourmet Facility

Drawing Title
 Floor Finishes + Reflected Ceiling Plans
 Ground Floor
 Unit 01


Drawn by: RKC	Scale: 1:100@A1	Date: 30.09.10
Designed by: FCG	Checked by: RKC	Approved by: AC

File Ref.: X:\FRANKHAM\CG\44272\ESTATION\CH010_196_LOCATION_PLAN_AND_GA_44272\A111.DWG - 200911160205 20.06.11.14.24.35

Drawing No. 440272-A-111	Rev. 04
-----------------------------	------------

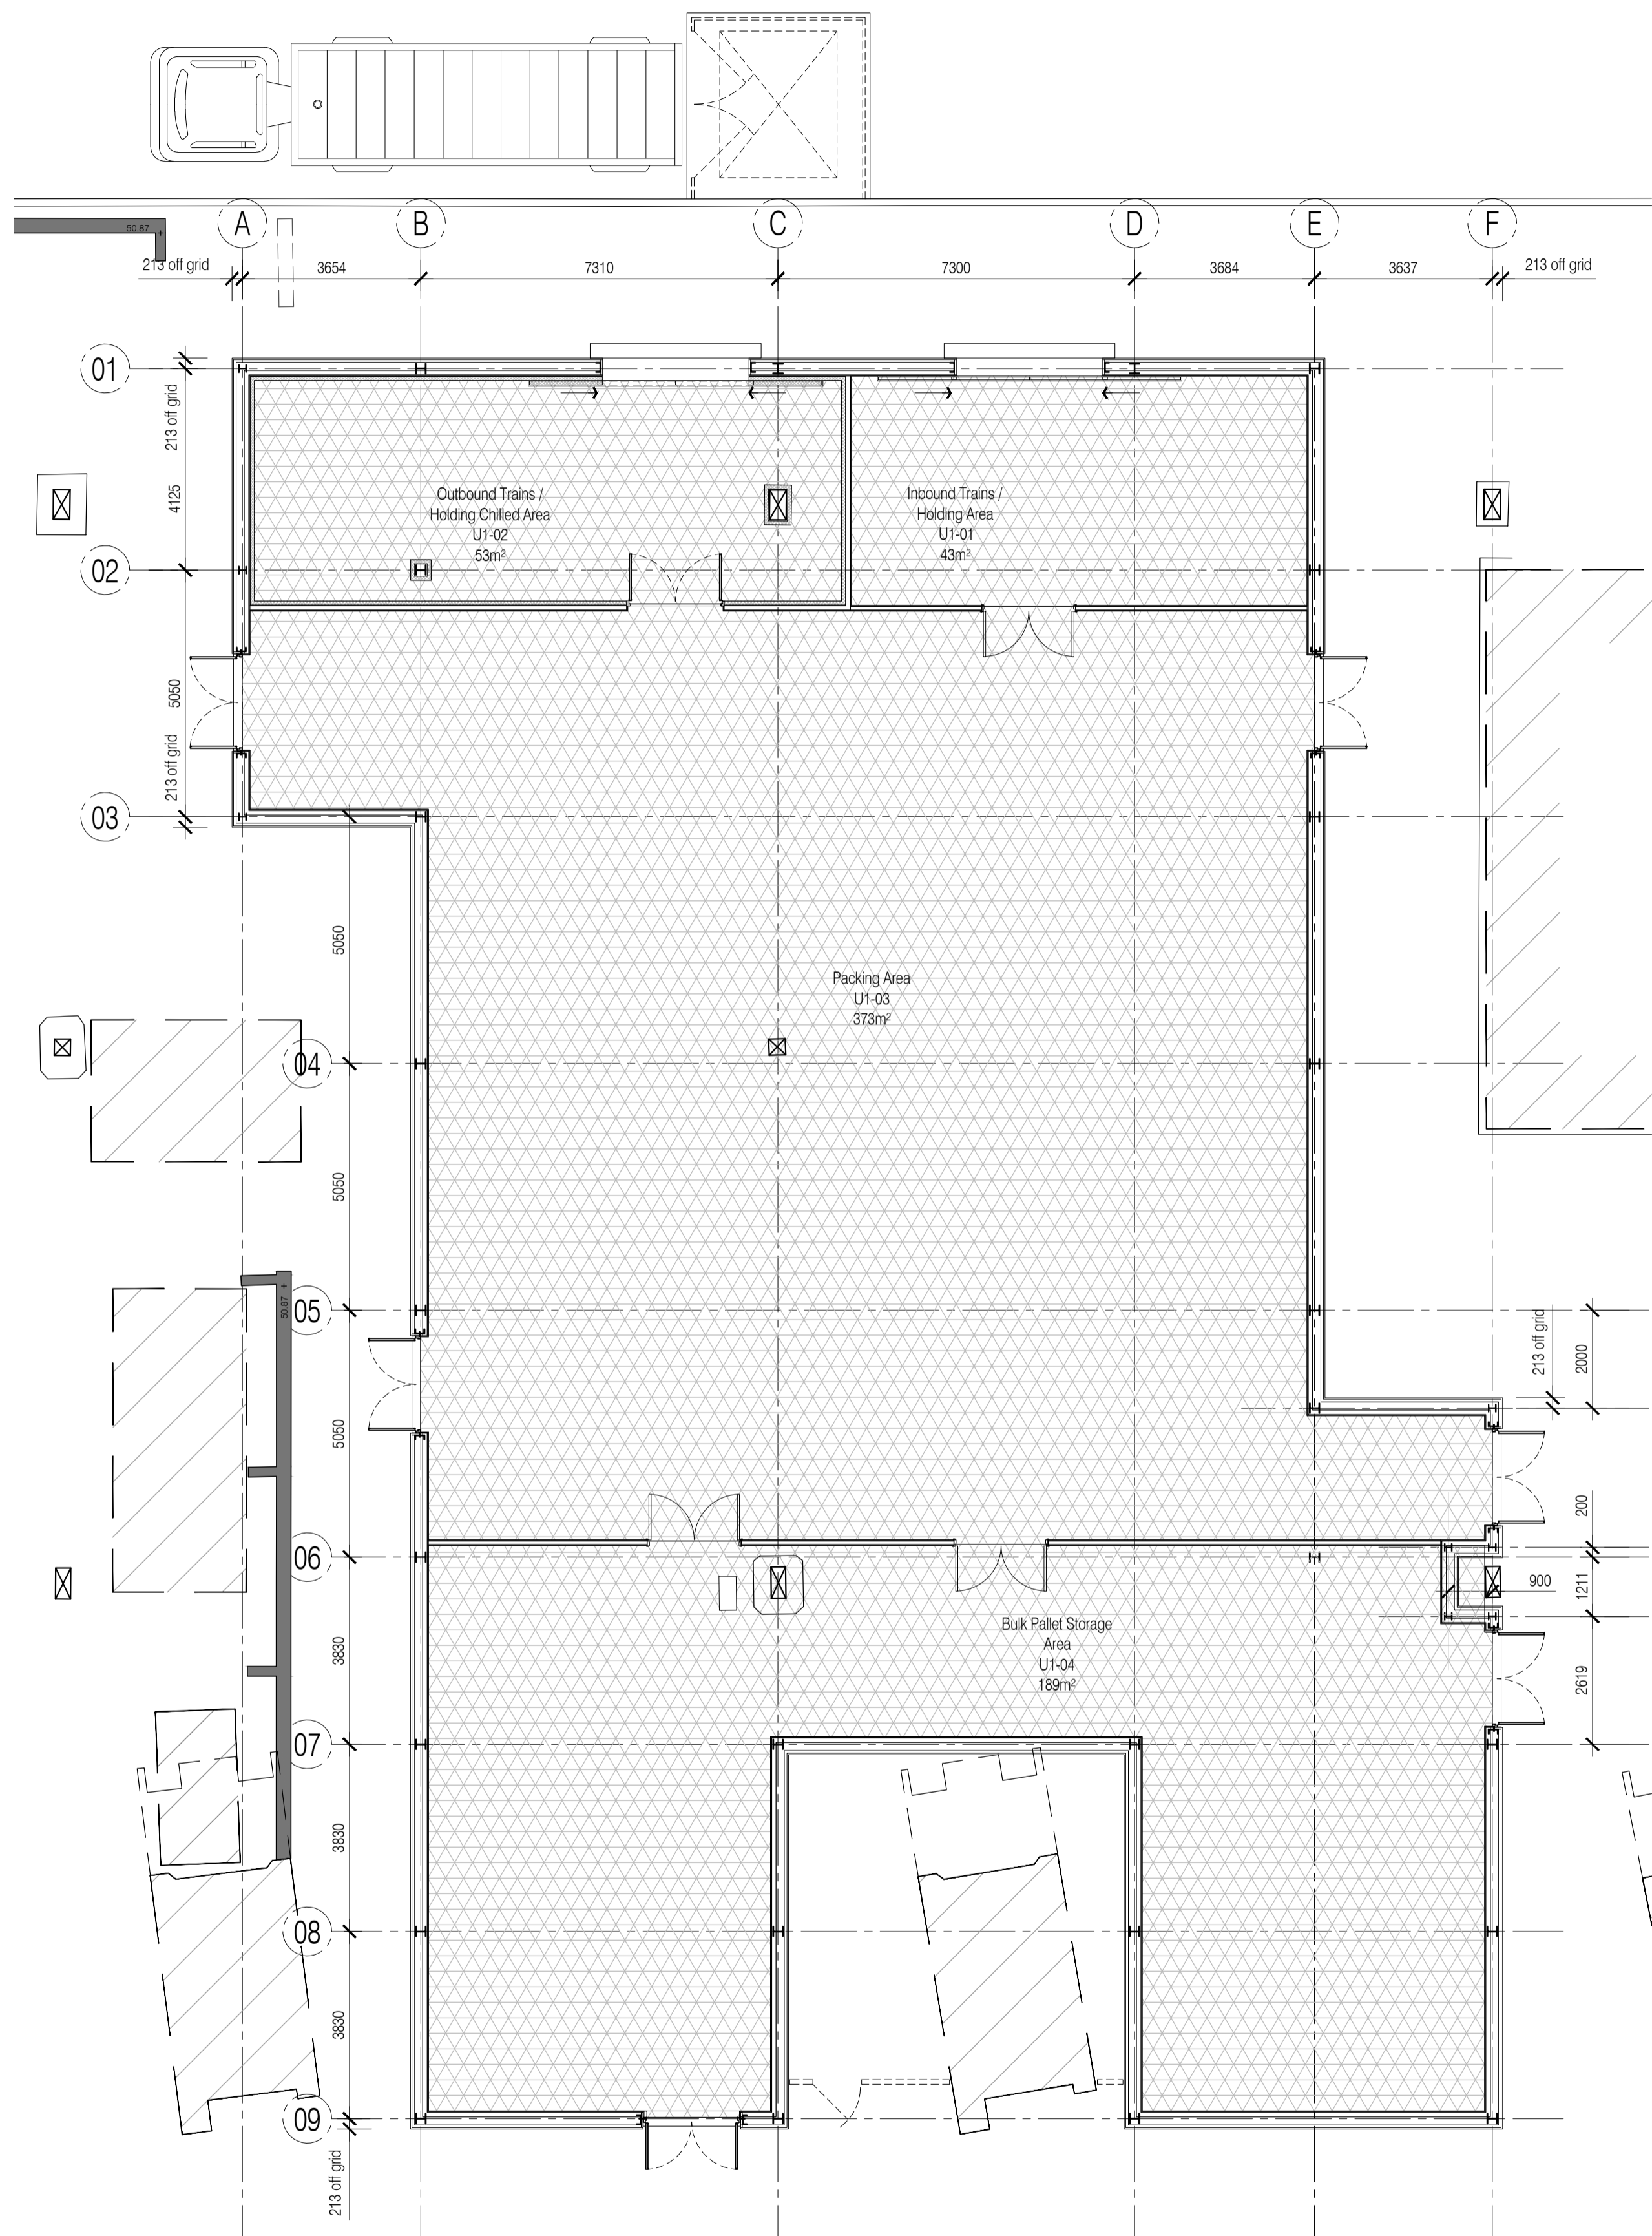

01 Unit 01 - Floor Finishes Plan
 Scale:1:100

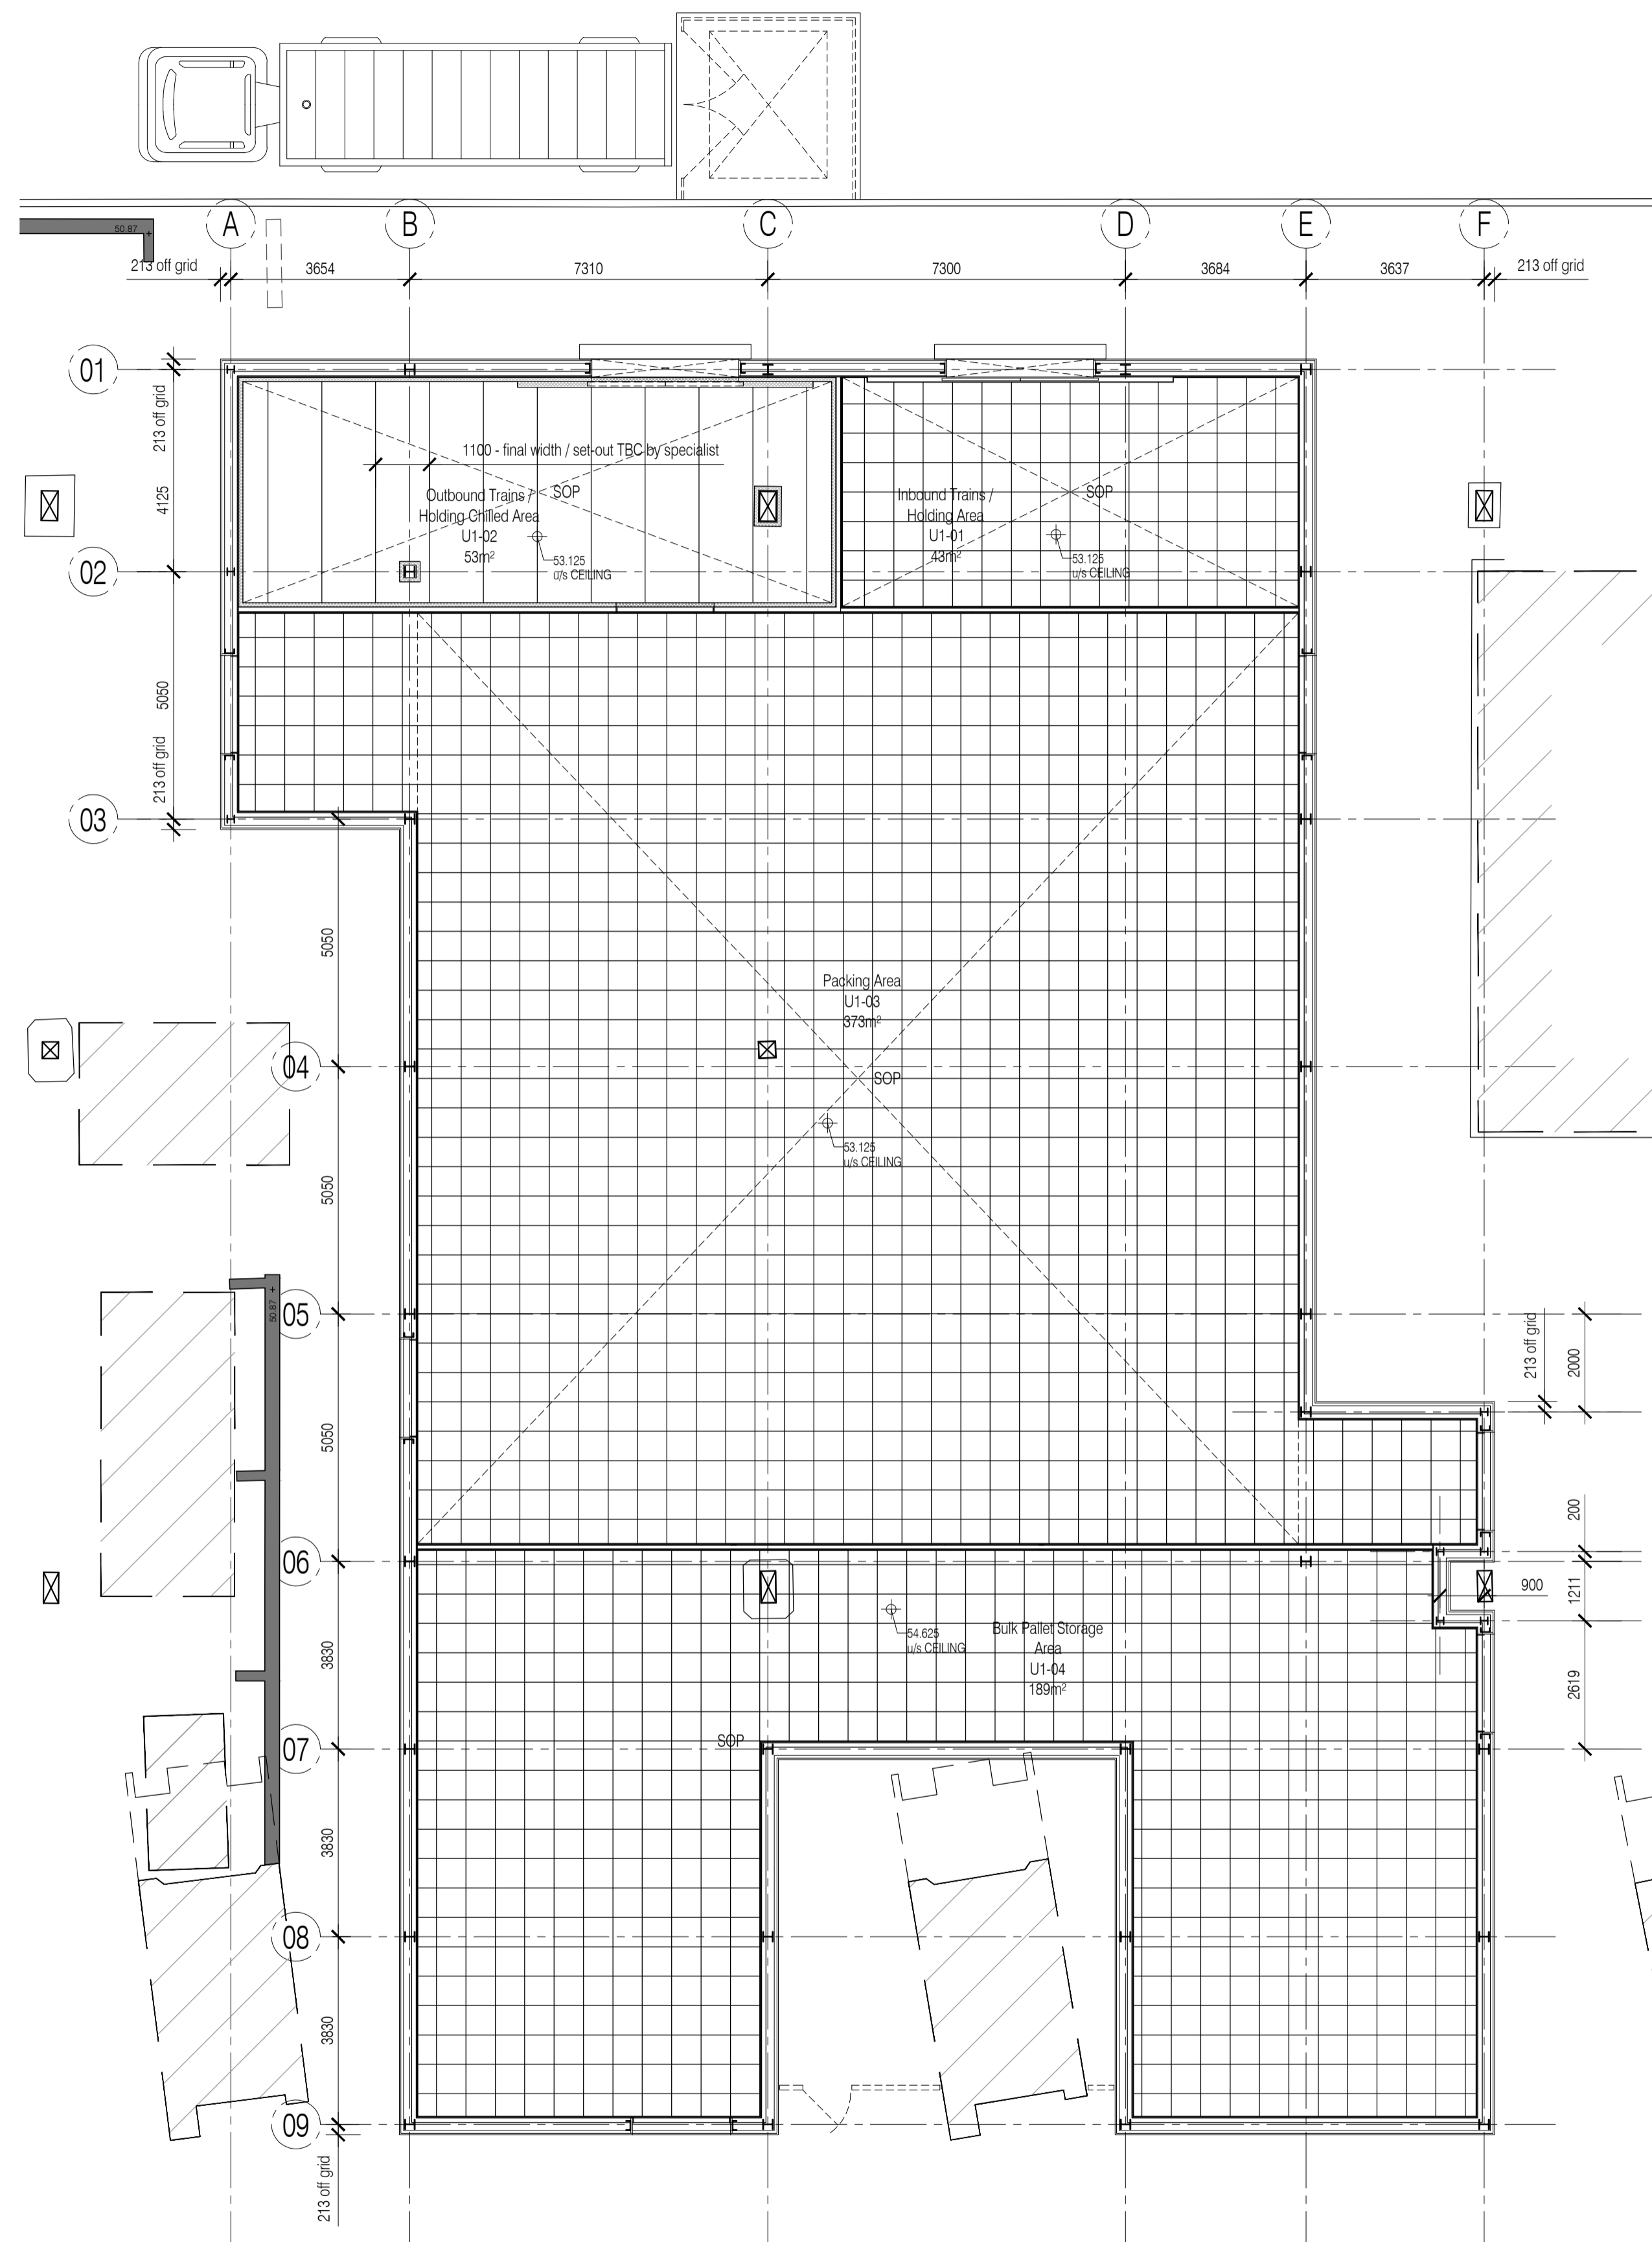

02 Unit 01 - Reflected Ceiling Plan
 Scale:1:100